


KEYPLAN

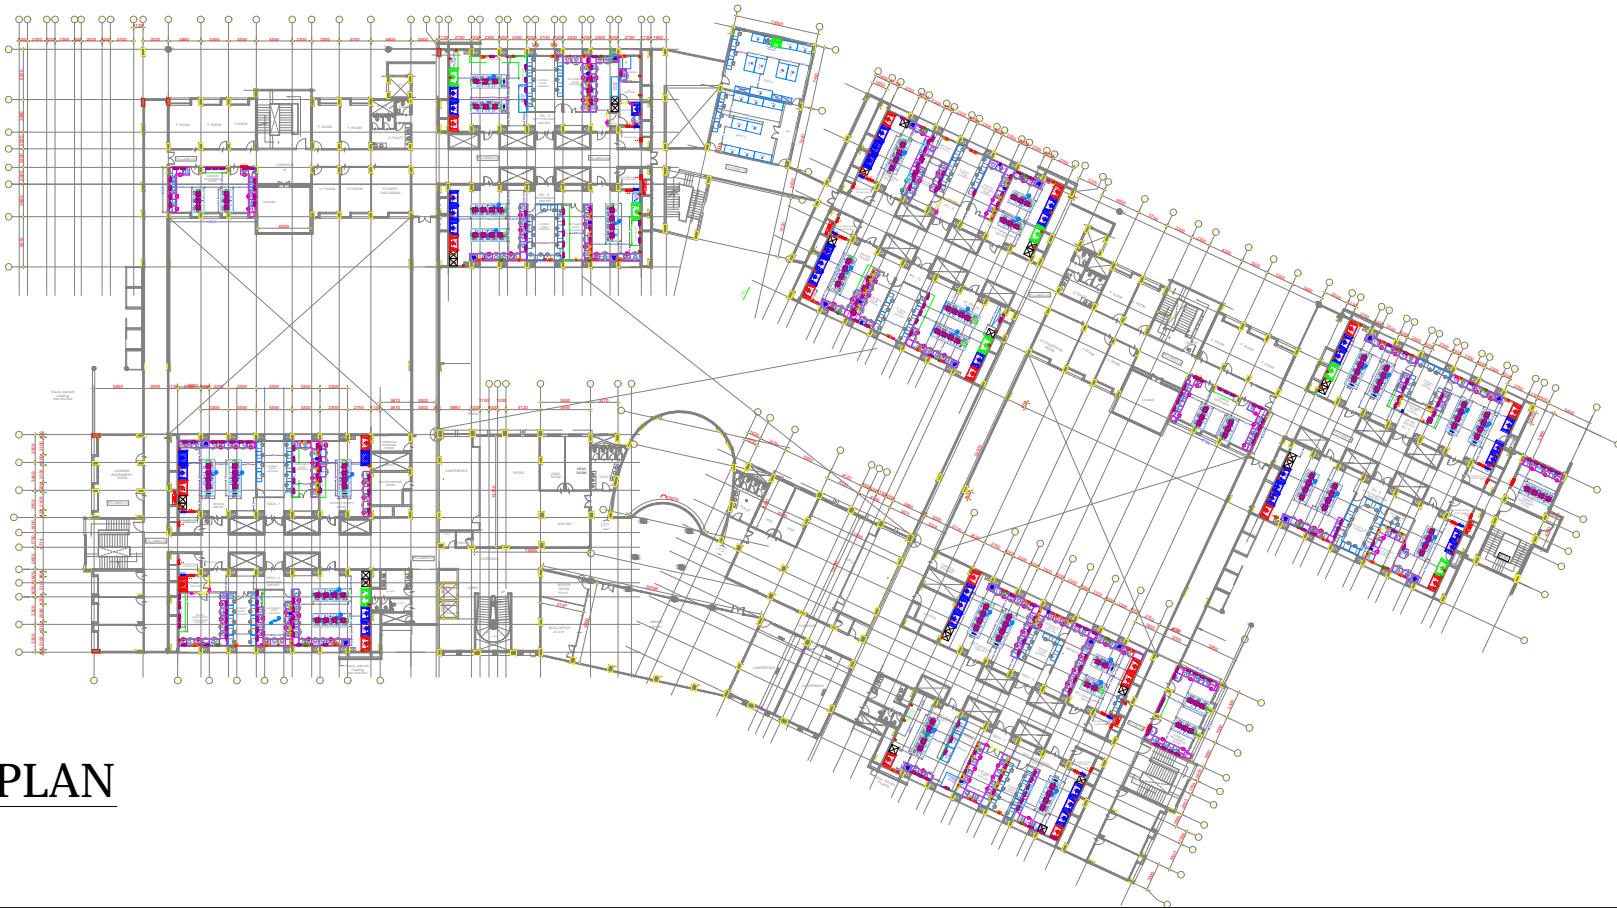

LEGEND(EXISTING POWER SOCKETS):

| SL.NO | SYMBOL | DESCRIPTION   |
|-------|--------|---|
| 01    |        | 2NOS OF 6/16A MODULAR RAW POWER SOCKET CONTROLLED BY 2NOS OF 16A SWITCH |
| 02    |        | 2NOS OF 6/16A MODULAR UPS POWER SOCKET CONTROLLED BY 2NOS OF 16A SWITCH |
| 03    |        | 20A 1PHASE 3PIN INDUSTRIAL PLUG & SOCKET CONTROLLED BY 20A SP MCB       |
| 04    |        | 32A 3PHASE 5PIN INDUSTRIAL PLUG & SOCKET CONTROLLED BY 32A TP MCB       |
| 05    |        | RAW POWER OF 20A DP MCB WITH ENCLOSURE                                  |

LEGEND(FF SSCU-7, DR.A.J.BHATTACHARYA):

| SL. NO | SYMBOL | DESCRIPTION  | QTY |
|--------|--------|--|-----|
| 01     |        | 1NO OF 6/16A MODULAR RAW POWER SOCKET CONTROLLED BY 16A SWITCH                           | 01  |
| 02     |        | 2NOS OF 6/16A MODULAR RAW POWER SOCKET CONTROLLED BY 2NOS OF 16A SWITCH                  | 38  |
| 03     |        | 2NOS OF 6/16A MODULAR UPS POWER SOCKET CONTROLLED BY 2NOS OF 16A SWITCH                  | 08  |
| 04     |        | 32A 3PHASE 5PIN INDUSTRIAL PLUG & SOCKET CONTROLLED BY 32A TP MCB WITH METAL BACKBOX     | 02  |
| 05     |        | 32A 3PHASE 5PIN UPS INDUSTRIAL PLUG & SOCKET CONTROLLED BY 32A TP MCB WITH METAL BACKBOX | 01  |

CLIENT:



INDIAN INSTITUTE OF SCIENCE, BANGALORE.

PROJECT:

LABORATORY INTERIOR WORKS FOR CHEMICAL SCIENCES BUILDING.

Architect:

Chandroo Iyer Associates  
NO 69, 15TH "A" CROSS, 6th MAIN  
MALLESWARAM  
BANGALORE 560 055.  
TEL - 80 - 23368319

Consultant:

M J ASSOCIATES  
PROJECT ENGINEERING CONSULTANTS  
#45, 1st Floor, 8th Main road,  
Vasanth nagar, Bangalore-560 052  
Tel:-22284583,22204636  
E-mail:-projects@mjassociates.in/www.mjassociates.in

DRAWING TITLE:

POWER LAYOUT FOR SSCU-7 AT FF 'C'  
BOTTOM WEST SIDE

DRAWING STATUS : TENDER DRAWINGS

|          |              |
|----------|--------------|
| DRAWN    | CHETAN       |
| CHECKED  | SANDEEPA     |
| APPROVED | MJA          |
| DATE     | 23.03.2019   |
| JOB NO   | MJ - 324     |
| DWG NO:  | ELE- 2442(m) |
| SCALE    | NTS          |
| REVISION | TR 0         |